



- LEGEND**
- ◀ DOUBLE ELECTRICAL OUTLET WITH GROUND FAULT
 - ▶ COMBINATION TELEPHONE AND DATA OUTLET
 - ▼ DOUBLE ELECTRICAL COUNTERTOP OUTLET
 - ↕ DOUBLE ELECTRICAL OUTLET AT CEILING
 - ⌋ APPLIANCE OUTLET
 - ⌋ DOUBLE ELECTRICAL OUTLET WITH TV
 - ⌋ DOUBLE ELECTRICAL OUTLET
 - ⌋ DOUBLE ELECTRICAL OUTLET
 - ⌋ ELECTRICAL PANEL
 - E.P. ELECTRICAL PANEL
 - H.E. HEATER
 - A.P. ACCESS PANEL FOR BATHTUB PLUMBING
 - EXTENT OF TILE BACK SPLASH
 - P PODIUM BATH
 - ⊕ DIMMER
 - \$ SINGLE-POLE LIGHT SWITCH
 - \$₃ THREE-WAY LIGHT SWITCH
 - \$₄ FOUR-WAY LIGHT SWITCH

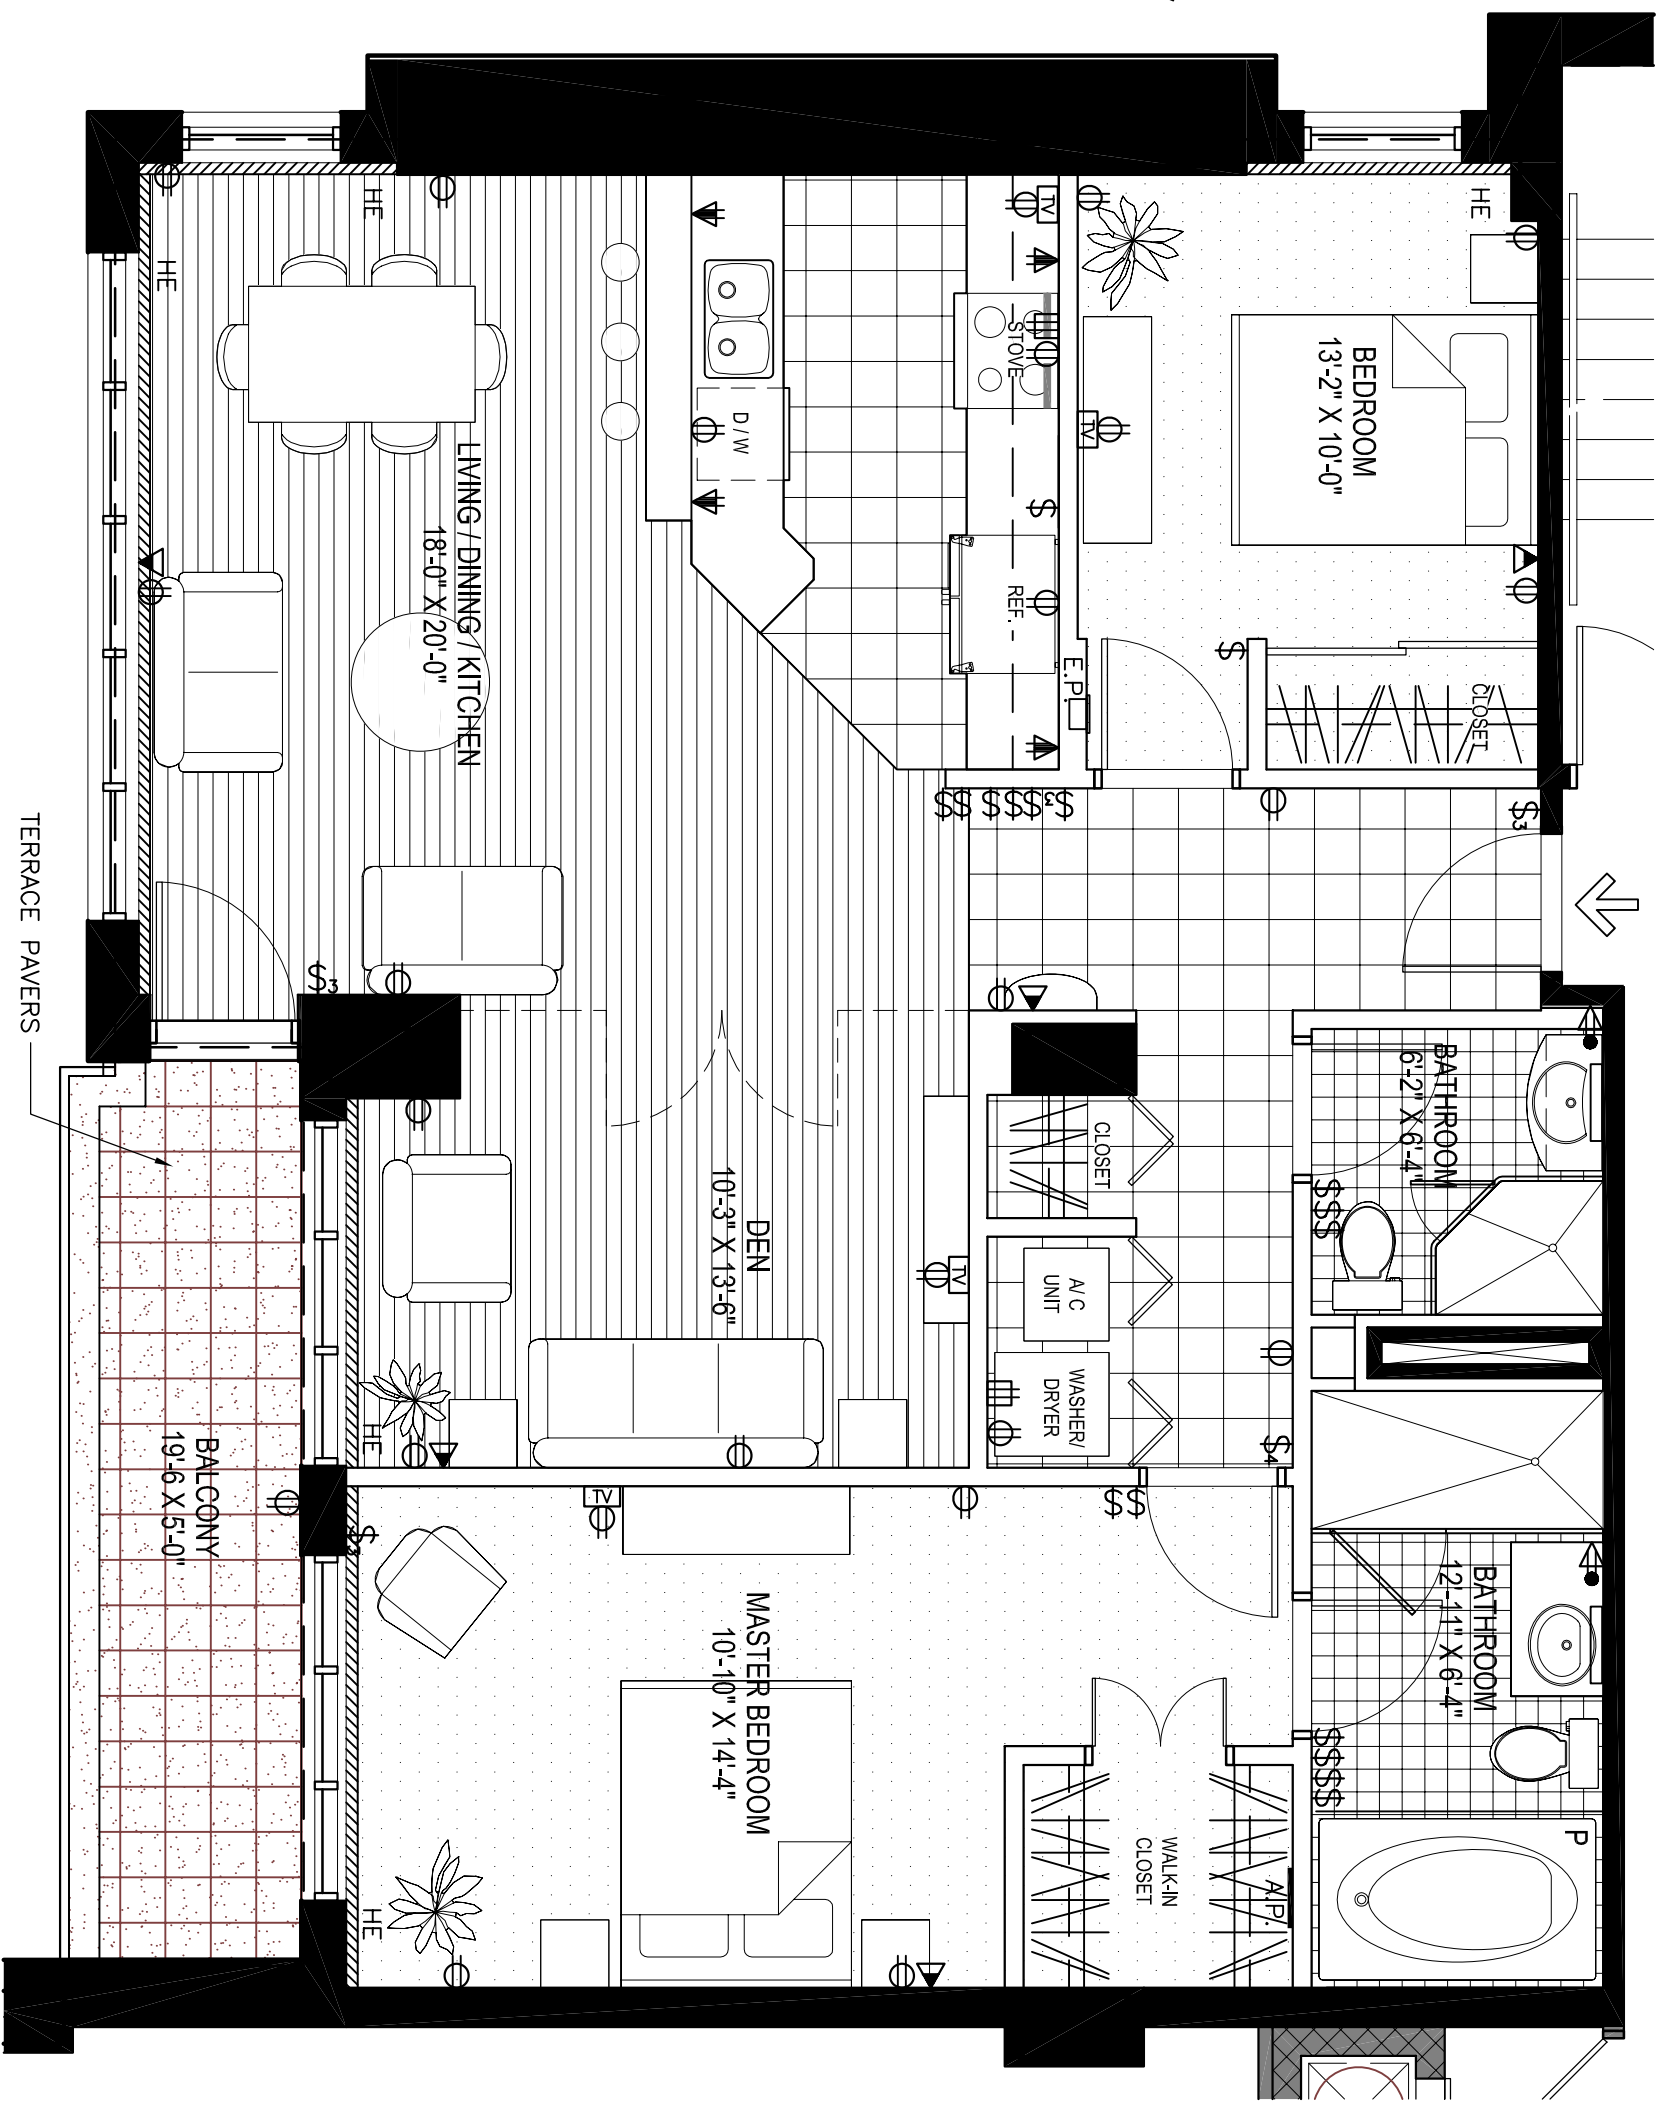

FLOOR PLAN scale: 1:50

REVISED 03-11-2006

- FLOOR FINISH LEGEND**
- ▨ ENGINEERED WOOD (SEE SPECIFICATIONS)
 - ▨ TILE 1 (SEE SPECIFICATIONS)
 - ▨ TILE 2 (SEE SPECIFICATIONS)
 - ▨ CARPET (SEE SPECIFICATIONS)
 - ▨ CONCRETE

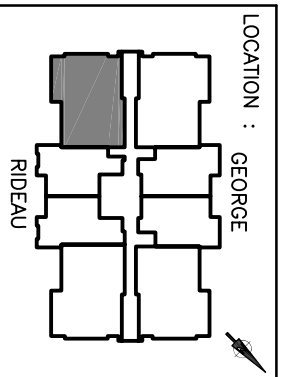

CONDO TYPE No.01 unit 501	AREA: 1 276 sq.ft 118.6 m²
---------------------------	----------------------------